


S.5. Emergency exits
are provided and
properly marked.

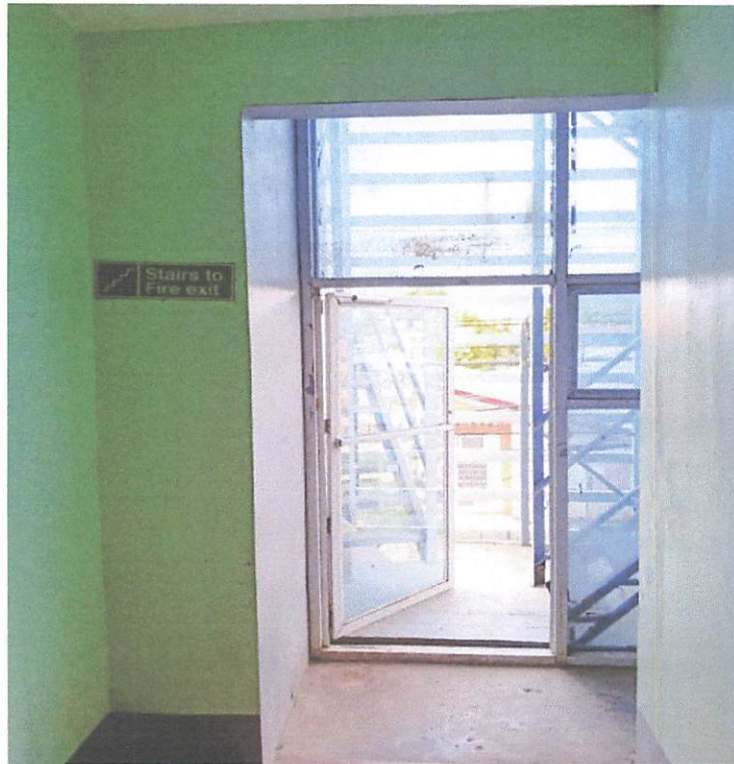

S.5. Emergency exits are provided and properly marked

SURIGAO STATE COLLEGE OF TECHNOLOGY
 MAIN CAMPUS, SURIGAO CITY

LEGEND:
 **EVACUATION AREA**





EMERGENCY NUMBER

- BFP: 232-7790/827-0318
- CRH: 862-1800/826-3876
- PNP HOTLINE: 09209745322
- PDRM: 09282105287
- CDRRMC: 826-5449/09106217684
- RESCUE: 09294209511

TO SURIGAO NORTE HIGH SCHOOL


 

 

SURIGAO CITY PILOT SCHOOL

TO PROVINCIAL GRANDSTAND

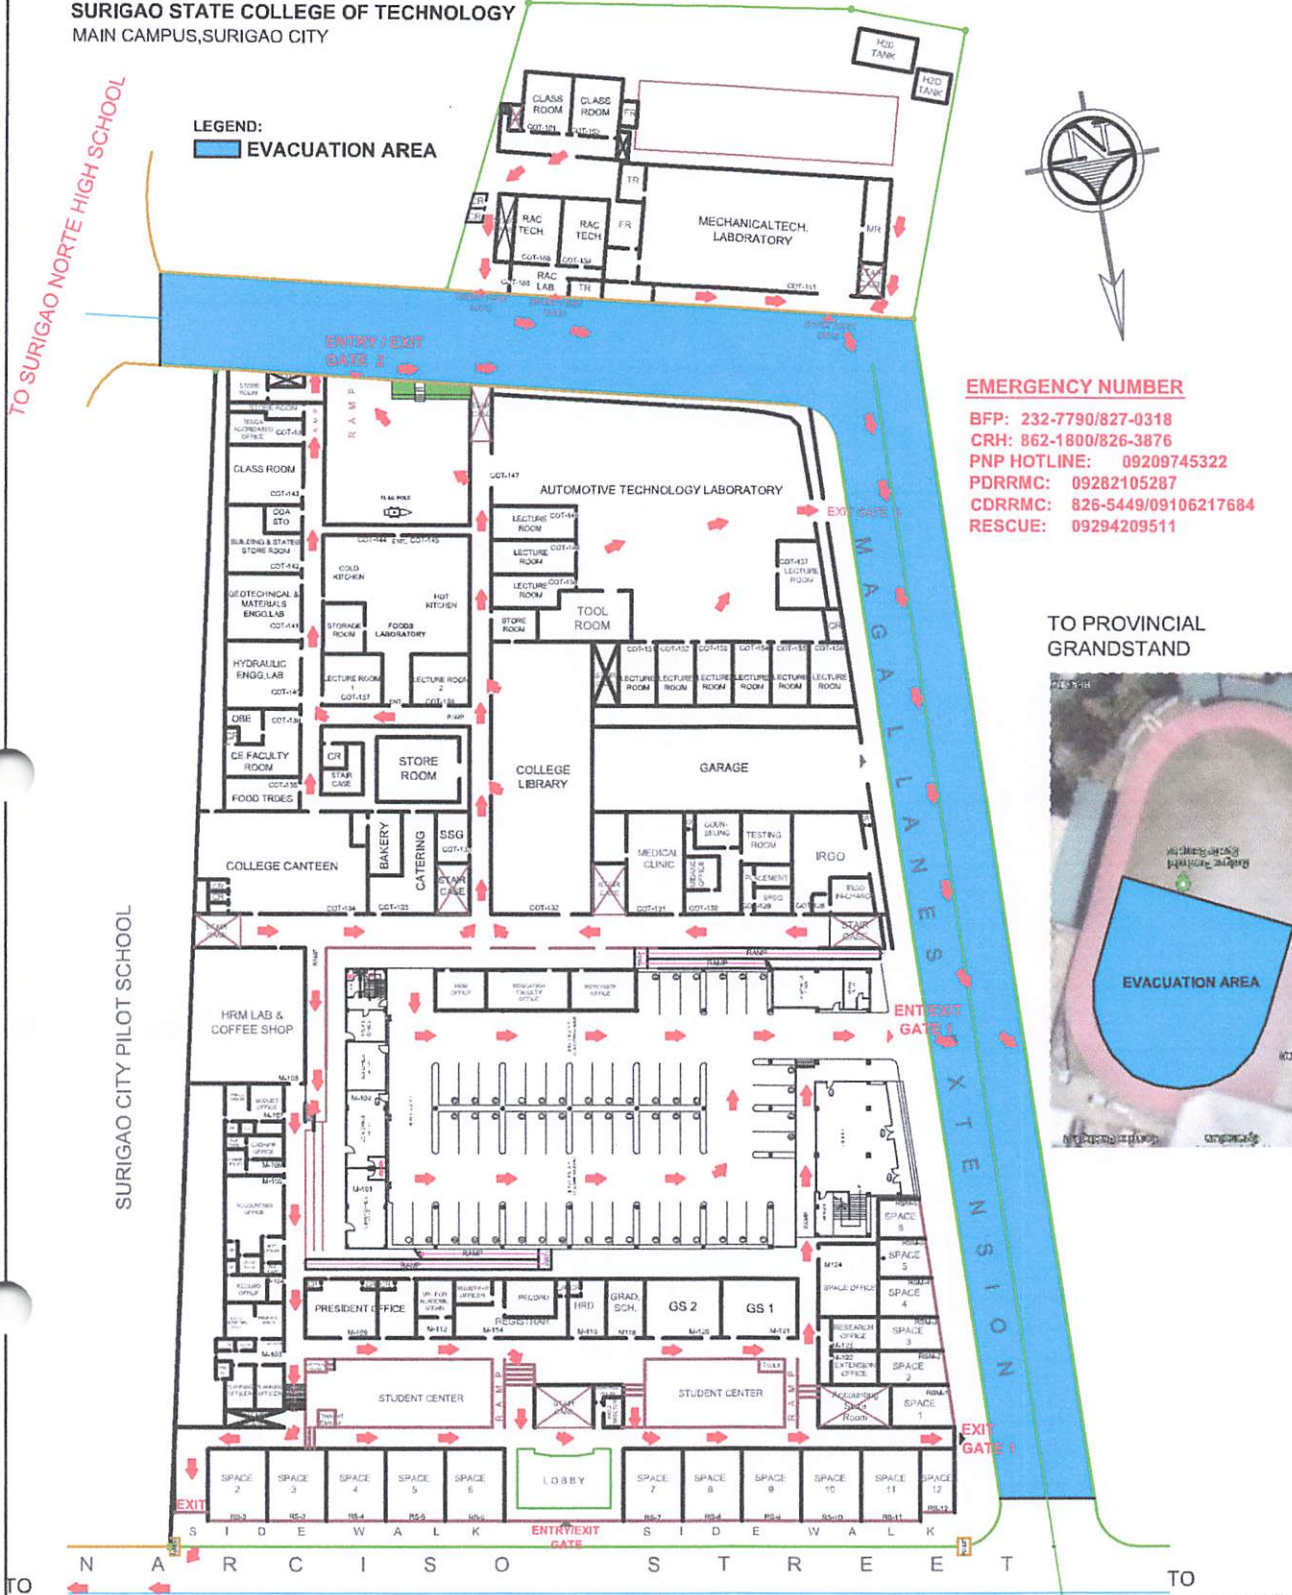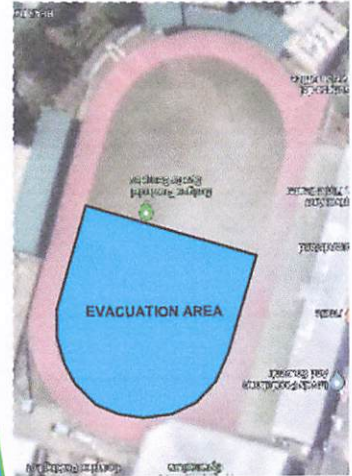


GROUND FLOOR PLAN

SCALE 1:500 M.

LOGO:	BY DIRECT SUPERVISION:	PROJECT TITLE:	RECOMMENDING APPROVAL :	APPROVED:	SHEET CONTENTS:	SHEET NO.:
	 AR. MARLON C. SOLLOSO HEAD BUILDINGS & ESTATES	EVACUATION EXIT PLAN COLLEGE BASED DISASTER CONTROL GROUP	 ROWENA A. PANDO, Ph.D. VICE-PRESIDENT for ADMINISTRATION	 GREGORIO Z. GAMBOA, JR., Ed.D. COLLEGE PRESIDENT		
SSCT		LOCATION: SSCT-MAIN CAMPUS, NARCISO ST., SURIGAO CITY				

**SURIGAO STATE COLLEGE OF TECHNOLOGY
MAIN CAMPUS, SURIGAO CITY**


LEGEND:
 **EVACUATION AREA**

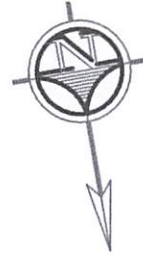

EMERGENCY NUMBER

BFP: 232-7790/827-0318
CRH: 862-1800/826-3876
PNP HOTLINE: 09209745322
PDRM: 09282105287
CDRRMC: 826-5449/09106217684
RESCUE: 09294209511

**TO PROVINCIAL
GRANDSTAND**

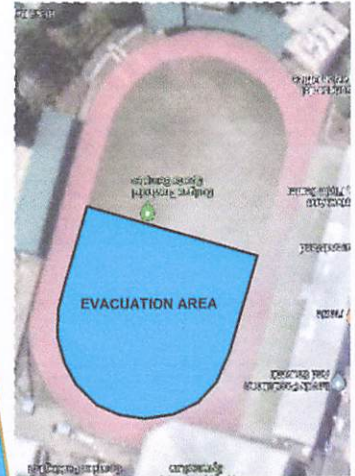

TO SURIGAO NORTE HIGH SCHOOL

SURIGAO CITY PILOT SCHOOL


 
 
 

MAGALLANES EXTENSION

TO PILOT SCHOOL

TO MC DONALD

SECOND FLOOR PLAN

SCALE 1:500 M.

LOGO:	BY DIRECT SUPERVISION:	PROJECT TITLE:	RECOMMENDING APPROVAL :	APPROVED:	SHEET CONTENTS:	SHEET NO.:
	 AR. MARLON C. SOLLOSO	EVACUATION EXIT PLAN COLLEGE BASED DISASTER CONTROL GROUP	 ROWENA A. PANDO, Ph.D.	 GREGORIO Z. GAMBOA, JR., Ed.D.		
SSCT	HEAD BUILDINGS & ESTATES	LOCATION: SSCT-MAIN CAMPUS, NARCISO ST., SURIGAO CITY	VICE-PRESIDENT for ADMINISTRATION	COLLEGE PRESIDENT		

**SURIGAO STATE COLLEGE OF TECHNOLOGY
MAIN CAMPUS, SURIGAO CITY**


LEGEND:
 **EVACUATION AREA**



EMERGENCY NUMBER

BFP: 232-7790/827-0318
CRH: 862-1800/826-3876
PNP HOTLINE: 09209745322
PDRRMC: 09282105287
CDRRMC: 826-5449/09106217684
RESCUE: 09294209511

**TO PROVINCIAL
GRANDSTAND**

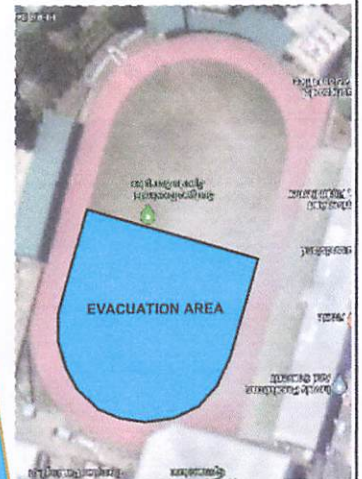


TO SURIGAO NORTE HIGH SCHOOL

SURIGAO CITY PILOT SCHOOL

MAGALLANES EXTENSION



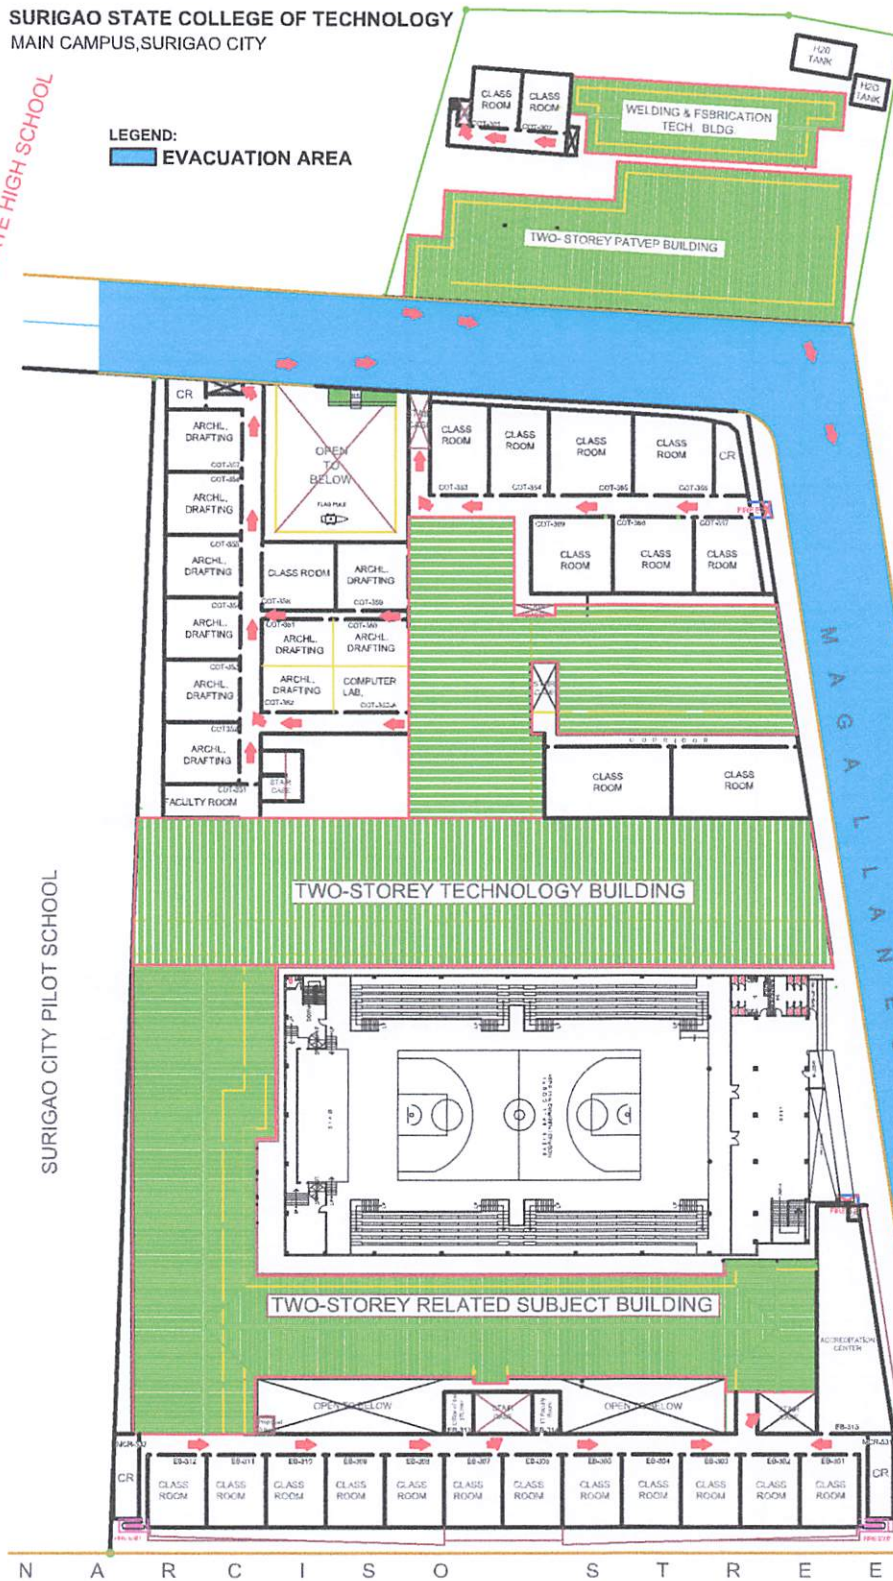


TO PILOT SCHOOL

TO MC DONALD



THIRD FLOOR PLAN

SCALE 1:500 M.

LOGO:	BY DIRECT SUPERVISION:	PROJECT TITLE:	RECOMMENDING APPROVAL:	APPROVED:	SHEET CONTENTS:	SHEET NO.:
	 AR. MARLON C. SOLLOSO	EVACUATION EXIT PLAN COLLEGE BASED DISASTER CONTROL GROUP	 ROWENA A. PANDO, Ph.D.	 GREGORIO Z. GAMBOA, JR., Ed.D.		
SSCT	HEAD BUILDINGS & ESTATES	LOCATION: SSCT-MAIN CAMPUS, NARCISO ST., SURIGAO CITY	VICE-PRESIDENT for ADMINISTRATION	COLLEGE PRESIDENT		

SURIGAO STATE COLLEGE OF TECHNOLOGY
 MAIN CAMPUS, SURIGAO CITY


LEGEND:
 **EVACUATION AREA**



EMERGENCY NUMBER


BFP: 232-7790/827-0318
 CRH: 862-1800/826-3876
 PNP HOTLINE: 09209745322
 PDRRC: 09282105287
 CDRRC: 826-5449/09106217684
 RESCUE: 09294209511

TO PROVINCIAL
 GRANDSTAND

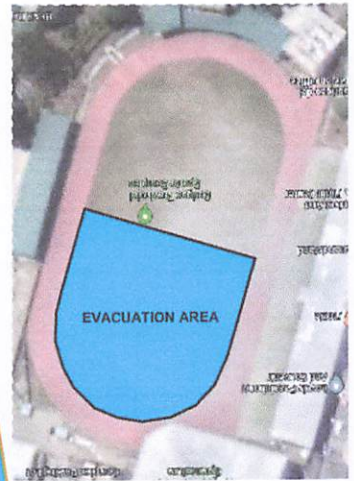


 

 

SURIGAO CITY PILOT SCHOOL

MAGALLANES EXTENSION

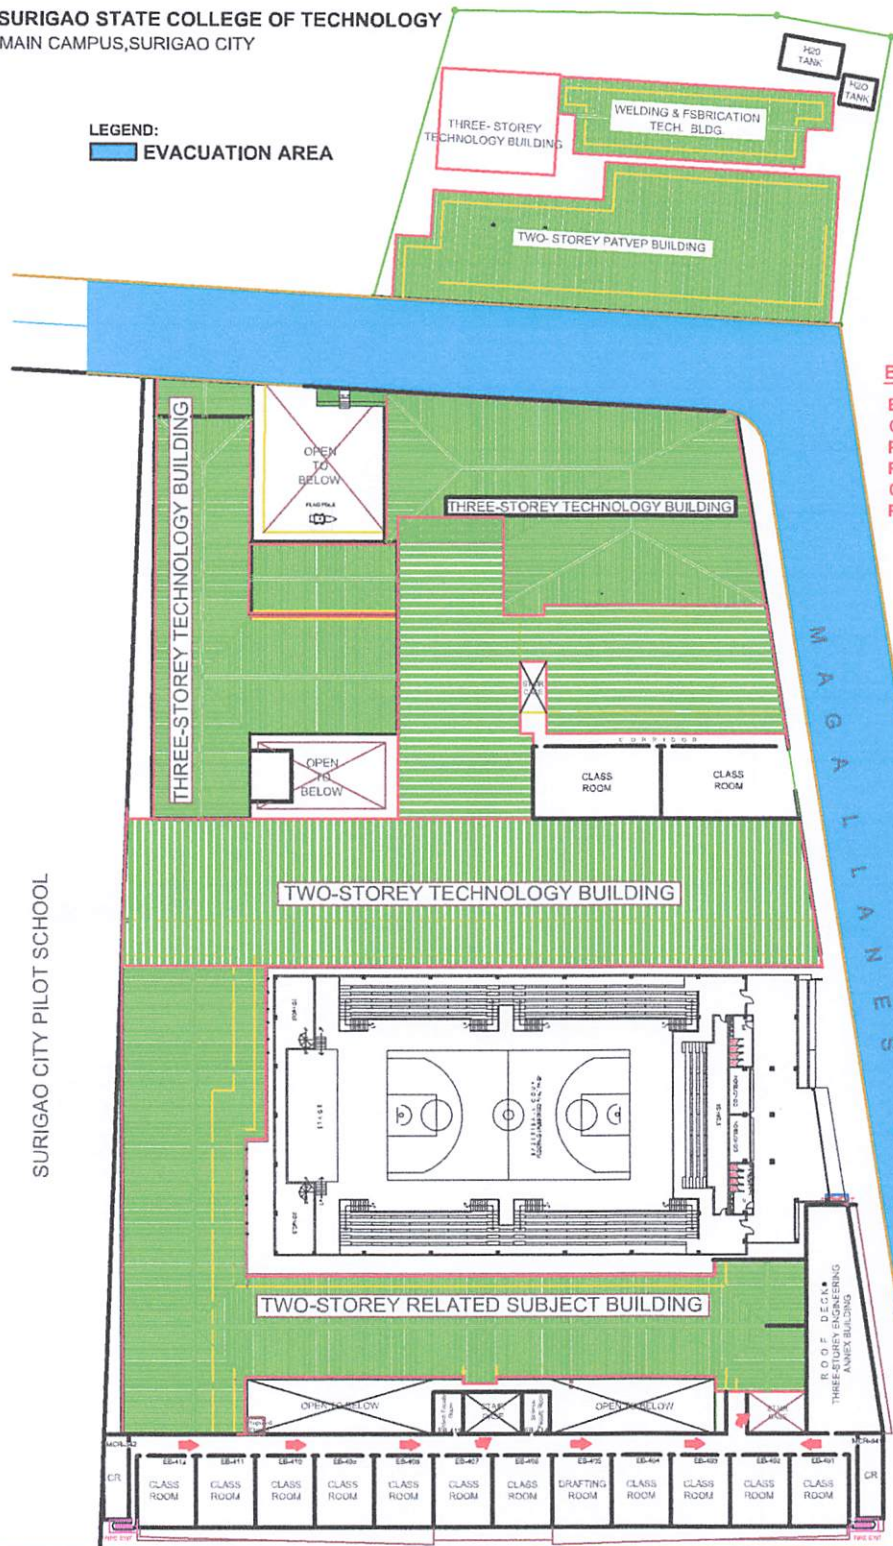

FOURTH FLOOR PLAN

SCALE 1:500 M.

LOGO:	BY DIRECT SUPERVISION:	PROJECT TITLE:	RECOMMENDING APPROVAL :	APPROVED:	SHEET CONTENTS:	SHEET NO.:
	 AR. MARLON C. SOLLOSO HEAD BUILDINGS & ESTATES	EVACUATION EXIT PLAN COLLEGE BASED DISASTER CONTROL GROUP	 ROWENA A. PLANDO, Ph.D. VICE-PRESIDENT for ADMINISTRATION	 GREGORIO Z. GAMBOA, JR., Ed.D. COLLEGE PRESIDENT		
SSCT		LOCATION: SSCT-MAIN CAMPUS, NARCISO ST., SURIGAO CITY				

SURIGAO STATE COLLEGE OF TECHNOLOGY
 MAIN CAMPUS, SURIGAO CITY



LEGEND:
 **EVACUATION AREA**



EMERGENCY NUMBER

BFP: 232-7790/827-0318
CRH: 862-1800/826-3876
PNP HOTLINE: 09209745322
PDRMC: 09282105287
CDRRMC: 826-5449/09106217684
RESCUE: 09294209511

TO PROVINCIAL GRANDSTAND

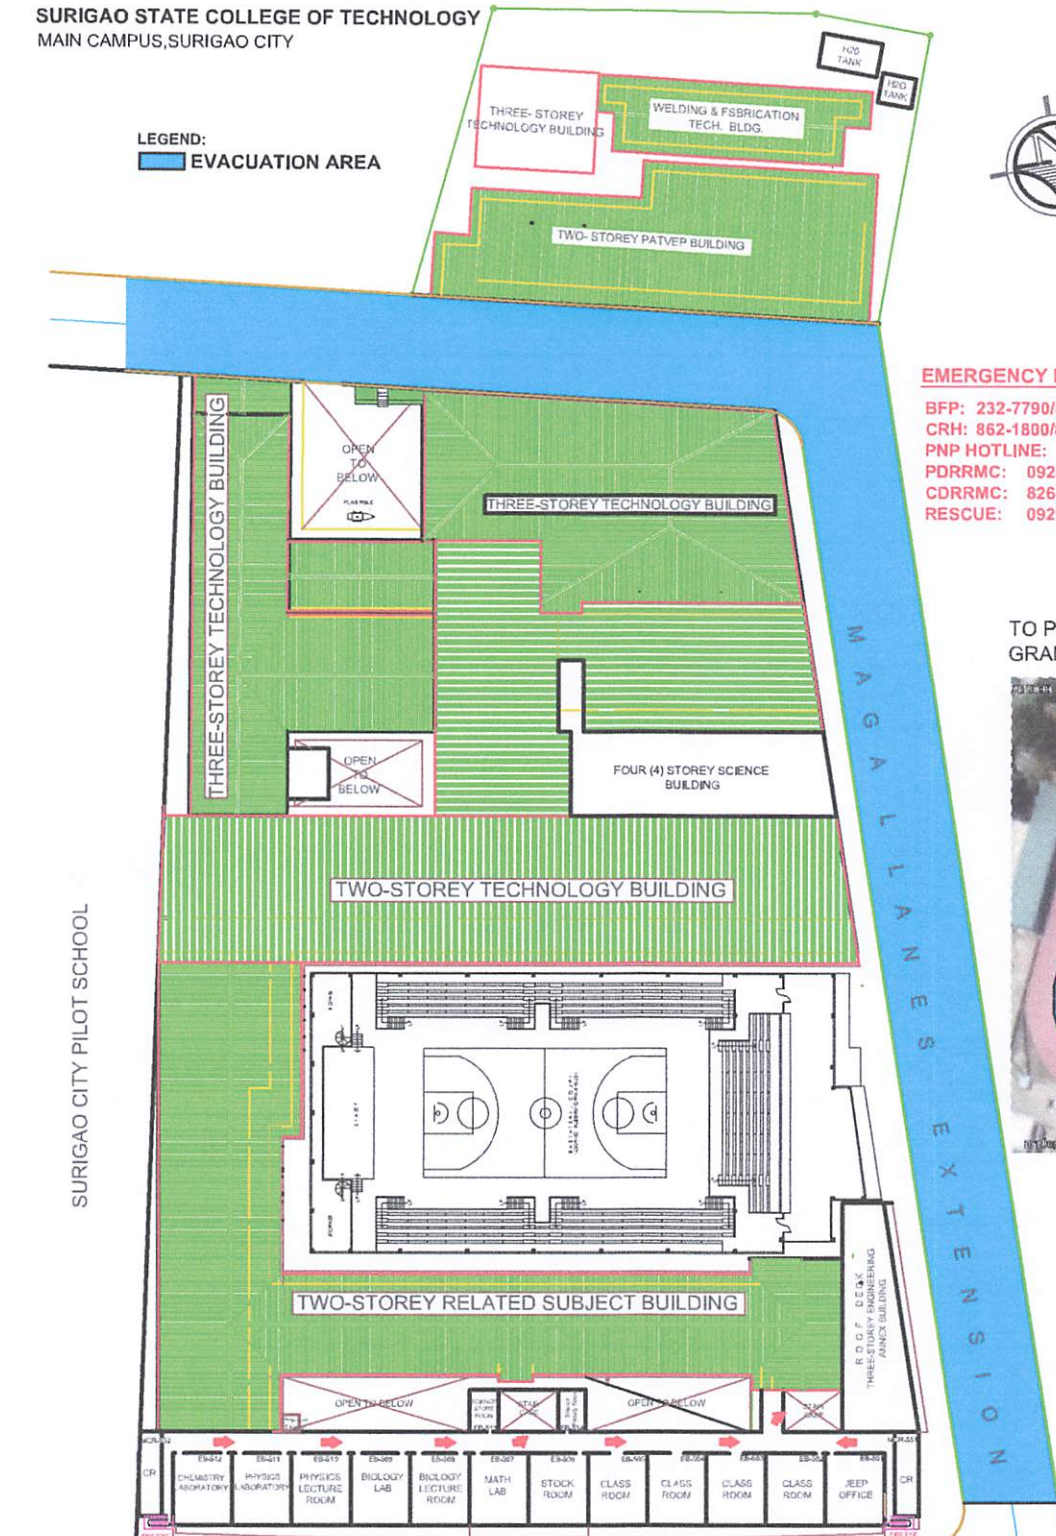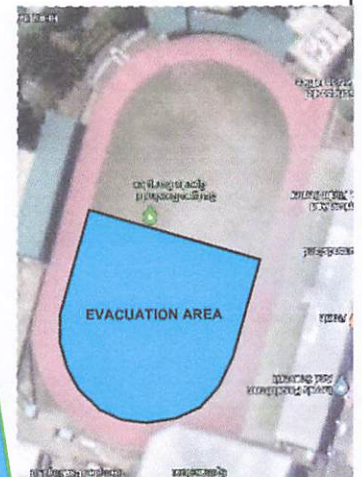


 
 
 

SURIGAO CITY PILOT SCHOOL

TO PILOT SCHOOL

TO MC DONALD

FIFTH FLOOR PLAN

SCALE 1:500 M.

LOGO:	BY DIRECT SUPERVISION:	PROJECT TITLE:	RECOMMENDING APPROVAL :	APPROVED:	SHEET CONTENTS:	SHEET NO.:
	 AR. MARLON C. SOLOSO	EVACUATION EXIT PLAN COLLEGE BASED DISASTER CONTROL GROUP	 ROWENA A. PANDO, Ph.D.	 GREGORIO Z. GAMBOA, JR. Ed.D.		
SSCT	HEAD BUILDINGS & ESTATES	LOCATION: SSCT-MAIN CAMPUS, NARCISO ST., SURIGAO CITY	VICE-PRESIDENT for ADMINISTRATION	COLLEGE PRESIDENT		