



Space Requirement

S.3. The size of the library meets standard requirements considering the present enrollment and future expansion.






Comparative Data on School's Population and Staff Ratio at SSCT

<i>CHED / AACUP STANDARDS</i>	<i>SSCT</i>
1 Licensed Librarian	7 Licensed Librarian
2 Full time Staff	1 Full time staff
500 Student population	5979 students population



INNOVATION CENTER
SSCT LEARNING RESOURCE CENTER

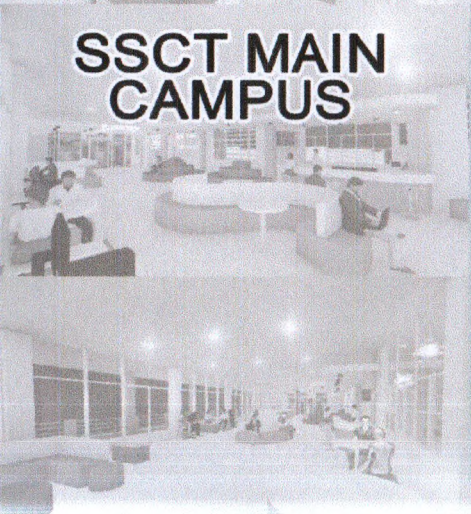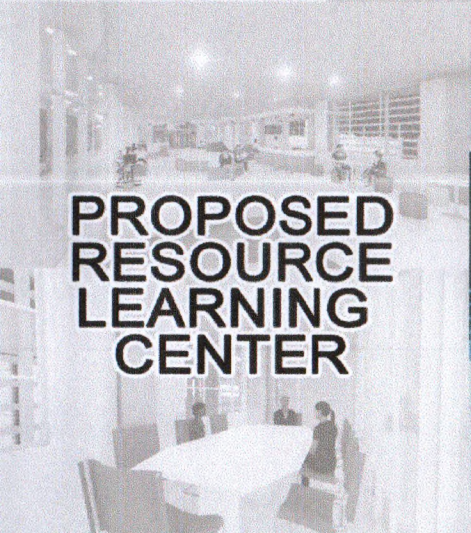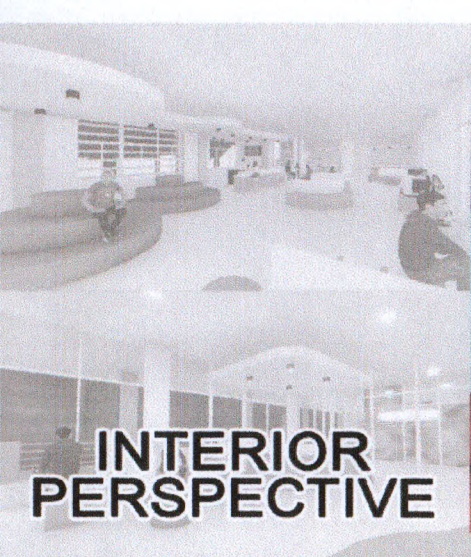



**INTERIOR
PERSPECTIVE**

**PROPOSED
RESOURCE
LEARNING
CENTER**

**SSCT MAIN
CAMPUS**




INTERNET ROOM
SSCT LEARNING RESOURCE CENTER

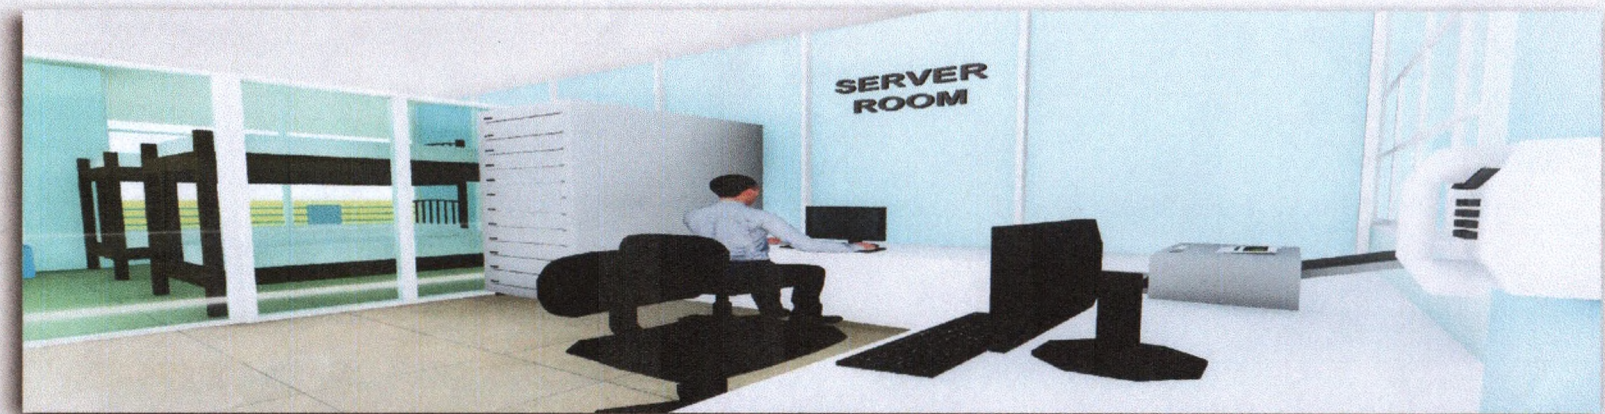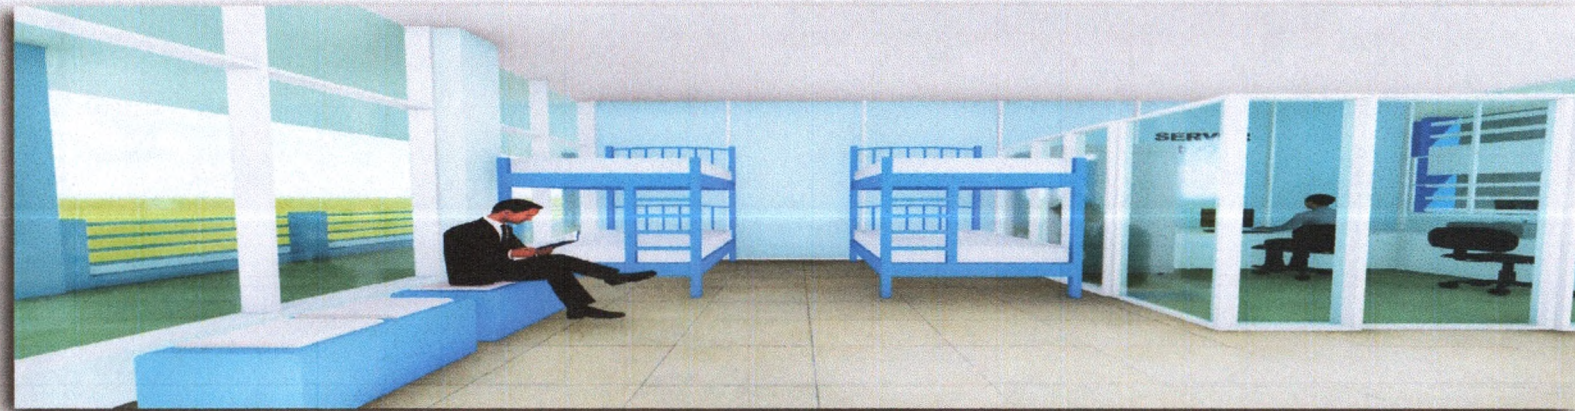



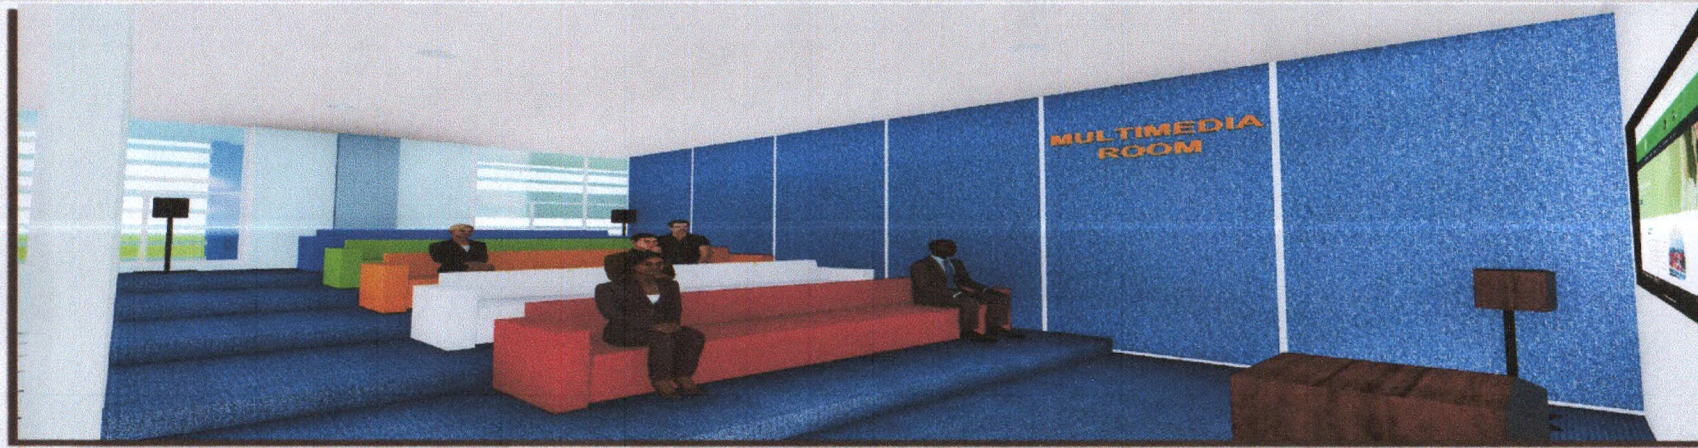

RESEARCH CORNER


SSCT LEARNING RESOURCE CENTER



MULTIMEDIA ROOM


SSCT LEARNING RESOURCE CENTER

 <p>SSCT</p>	<p>COLLEGE LOGO: BY DIRECT SUPERVISION:</p>  <p>AR. MARLON C. SOLLOSO HEAD BUILDINGS & ESTATES</p>	<p>PROJECT TITLE:</p> <p>LOCATION MAP</p> <p>LOCATION: SSCT-MAIN CAMPUS, SURIGAO CITY, SDN</p>	<p>RECOMMENDING APPROVAL:</p>  <p>ROWENA M. PLANDO, Ph.D. VICE-PRESIDENT for ADMINISTRATION</p>	<p>APPROVED:</p>  <p>GREGORIO Z. GAMBIA, Jr., Ed.D. COLLEGE PRESIDENT</p>	<p>CONTENT:</p> <p>SHEET NO.</p>
---	---	--	--	--	----------------------------------

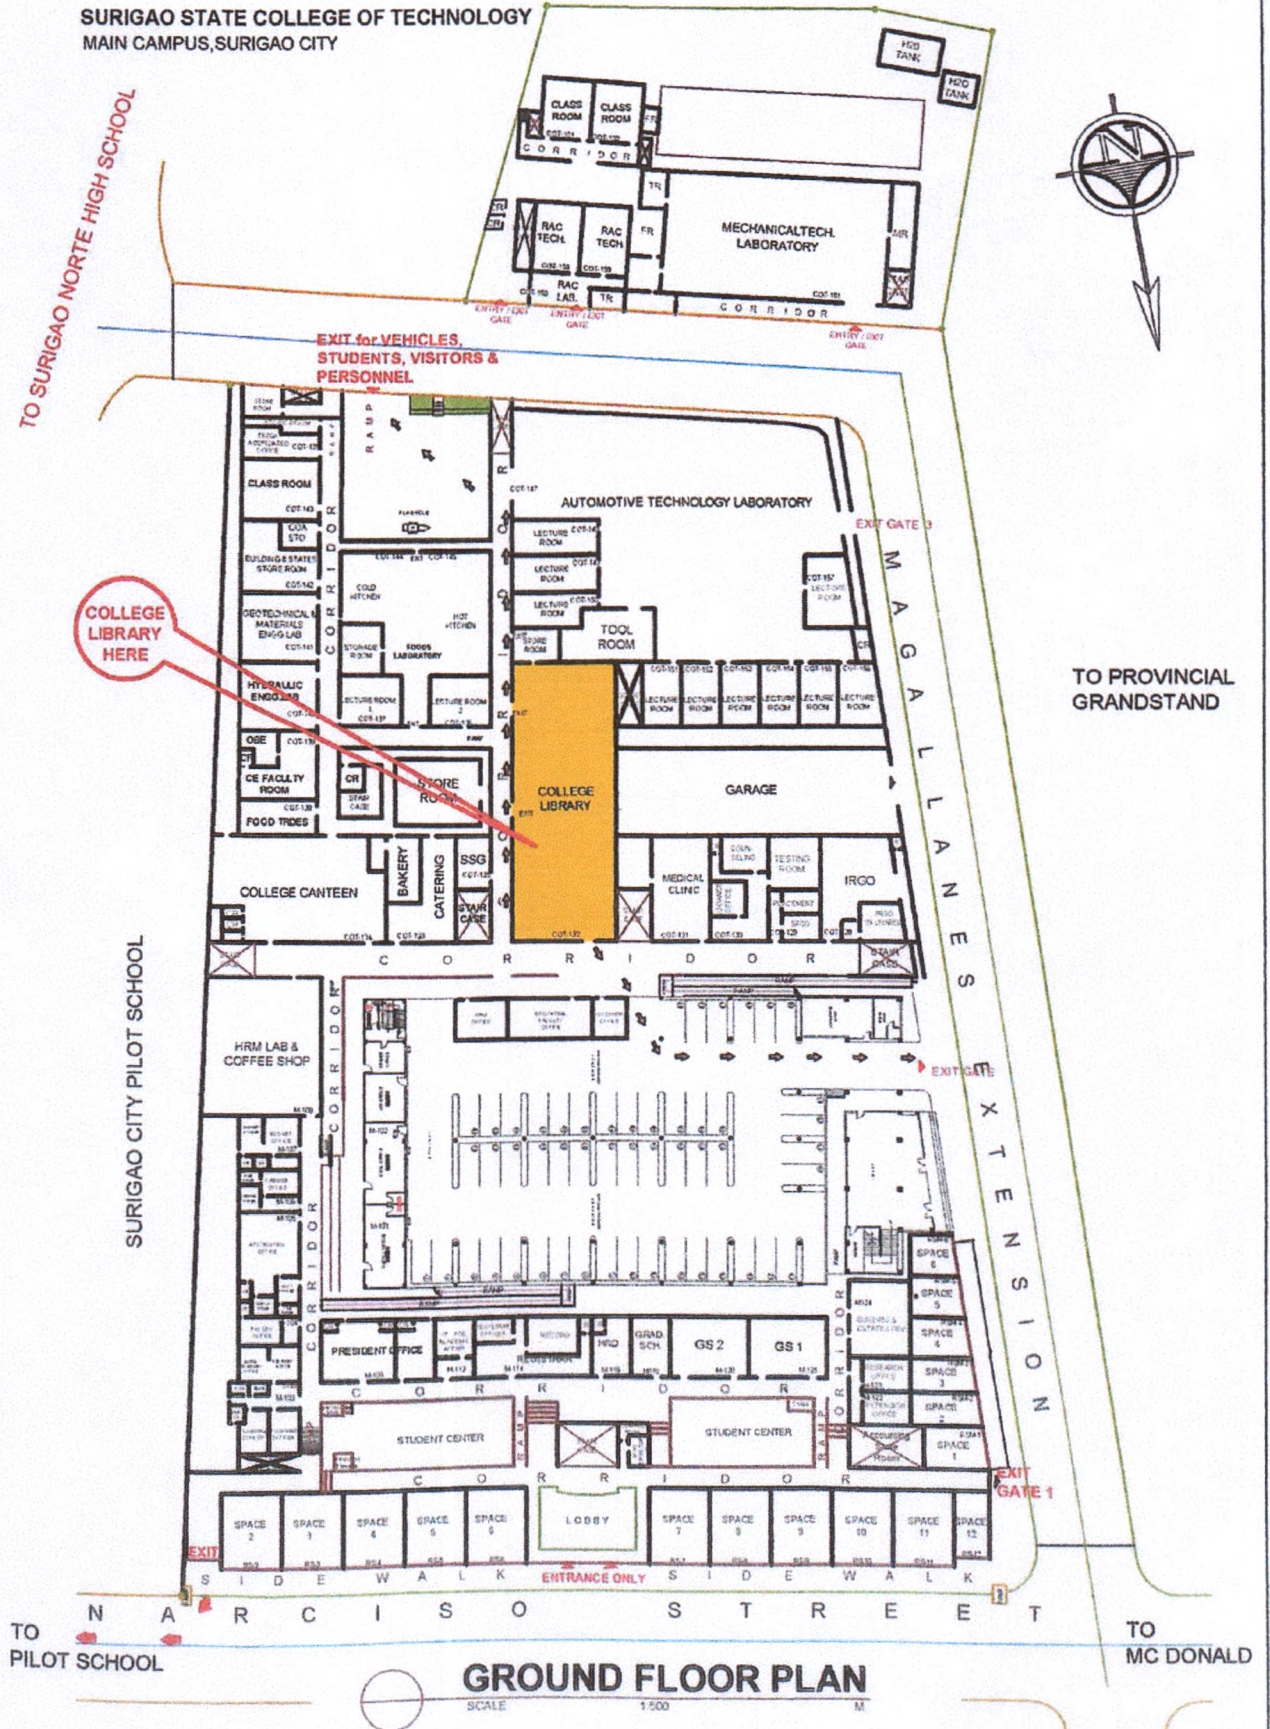

COLLEGE LIBRARY

**SURIGAO STATE COLLEGE OF TECHNOLOGY
MAIN CAMPUS, SURIGAO CITY**

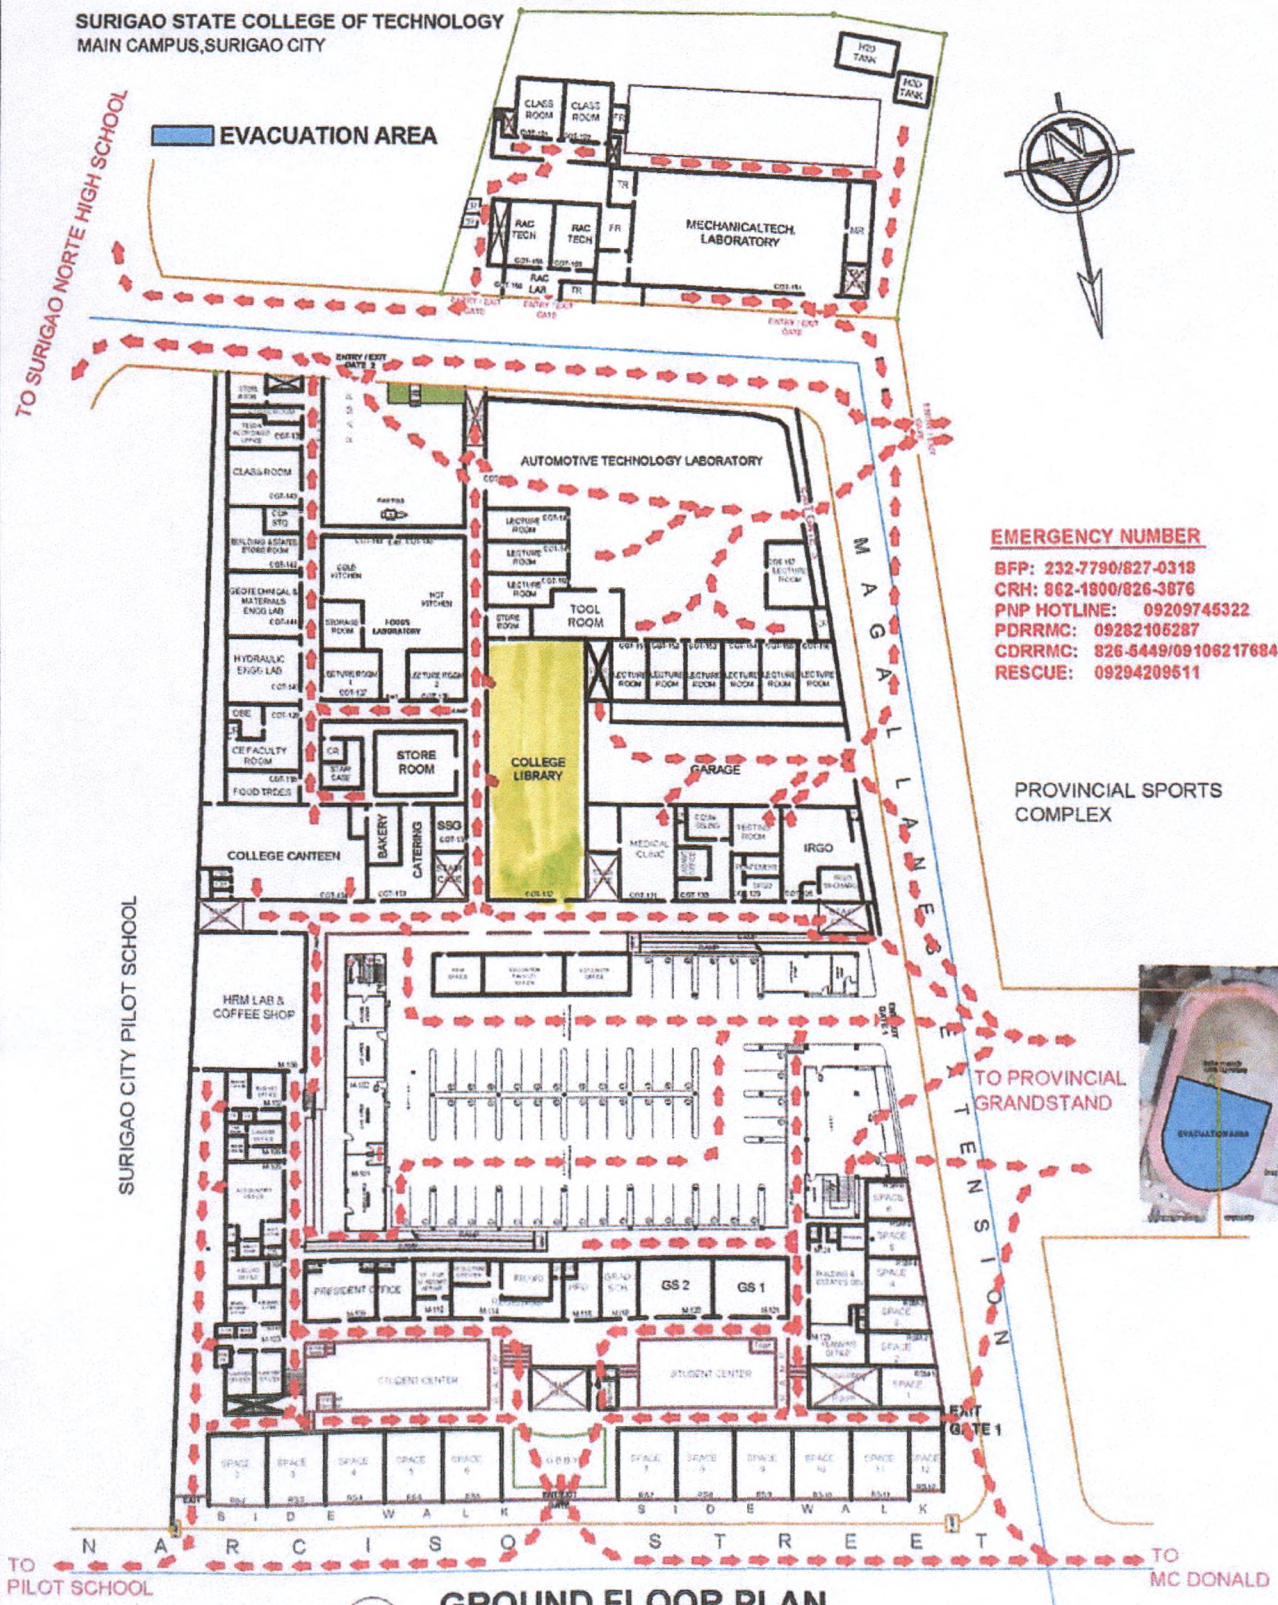


EMERGENCY NUMBER

BFP: 232-7790/827-0318
 CRH: 862-1900/826-3876
 PNP HOTLINE: 09209745322
 PDRRC: 09282106287
 CDRRC: 826-5449/09106217684
 RESCUE: 09294209511

PROVINCIAL SPORTS
COMPLEX

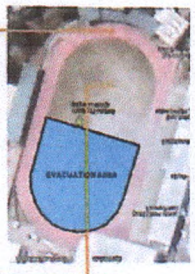

TO PROVINCIAL
GRANDSTAND




GROUND FLOOR PLAN

SCALE 1:500 M

LOGO	BY DIRECT SUPERVISION	PROJECT TITLE	RECOMMENDING APPROVAL	APPROVED	SHEET CONTENTS	SHEET NO.
	 AR. MARLON C. SOLLOSO	EMERGENCY EXIT PLAN/ EVACUATION EXIT PLAN	 ROWENA A. PANDO, Ph.D. VICE-PRESIDENT for ADMINISTRATION	 GREGORIO Z. GAMBOA, JR., Ed.D. COLLEGE PRESIDENT		⊕
SSCT	HEAD BUILDINGS & ESTATES	LOCATION: SSCT-MAIN CAMPUS, NARCISO ST., SURIGAO CITY				

 <p>SSCT</p>	<p>COLLEGE LOGO:</p> <p>BY DIRECT SUPERVISION:</p> <p>AR. MARLEN C. SOLOSO</p>	<p>PROJECT TITLE:</p> <p>LOCATION MAP</p>	<p>RECOMMENDING APPROVAL:</p> <p>ROWENA A. PLANDO, Ph.D.</p>	<p>APPROVED:</p> <p>GREGORIO Z. GAMBOA, Jr., Ed.D.</p>	<p>CONTENT:</p> <p>SHEET NO. </p>
<p>HEAD BUILDINGS & ESTATES</p>	<p>LOCATION: SSCT-MAIN CAMPUS, SURIGAO CITY, SDN</p>	<p>VICE-PRESIDENT for ADMINISTRATION</p>	<p>COLLEGE PRESIDENT</p>		


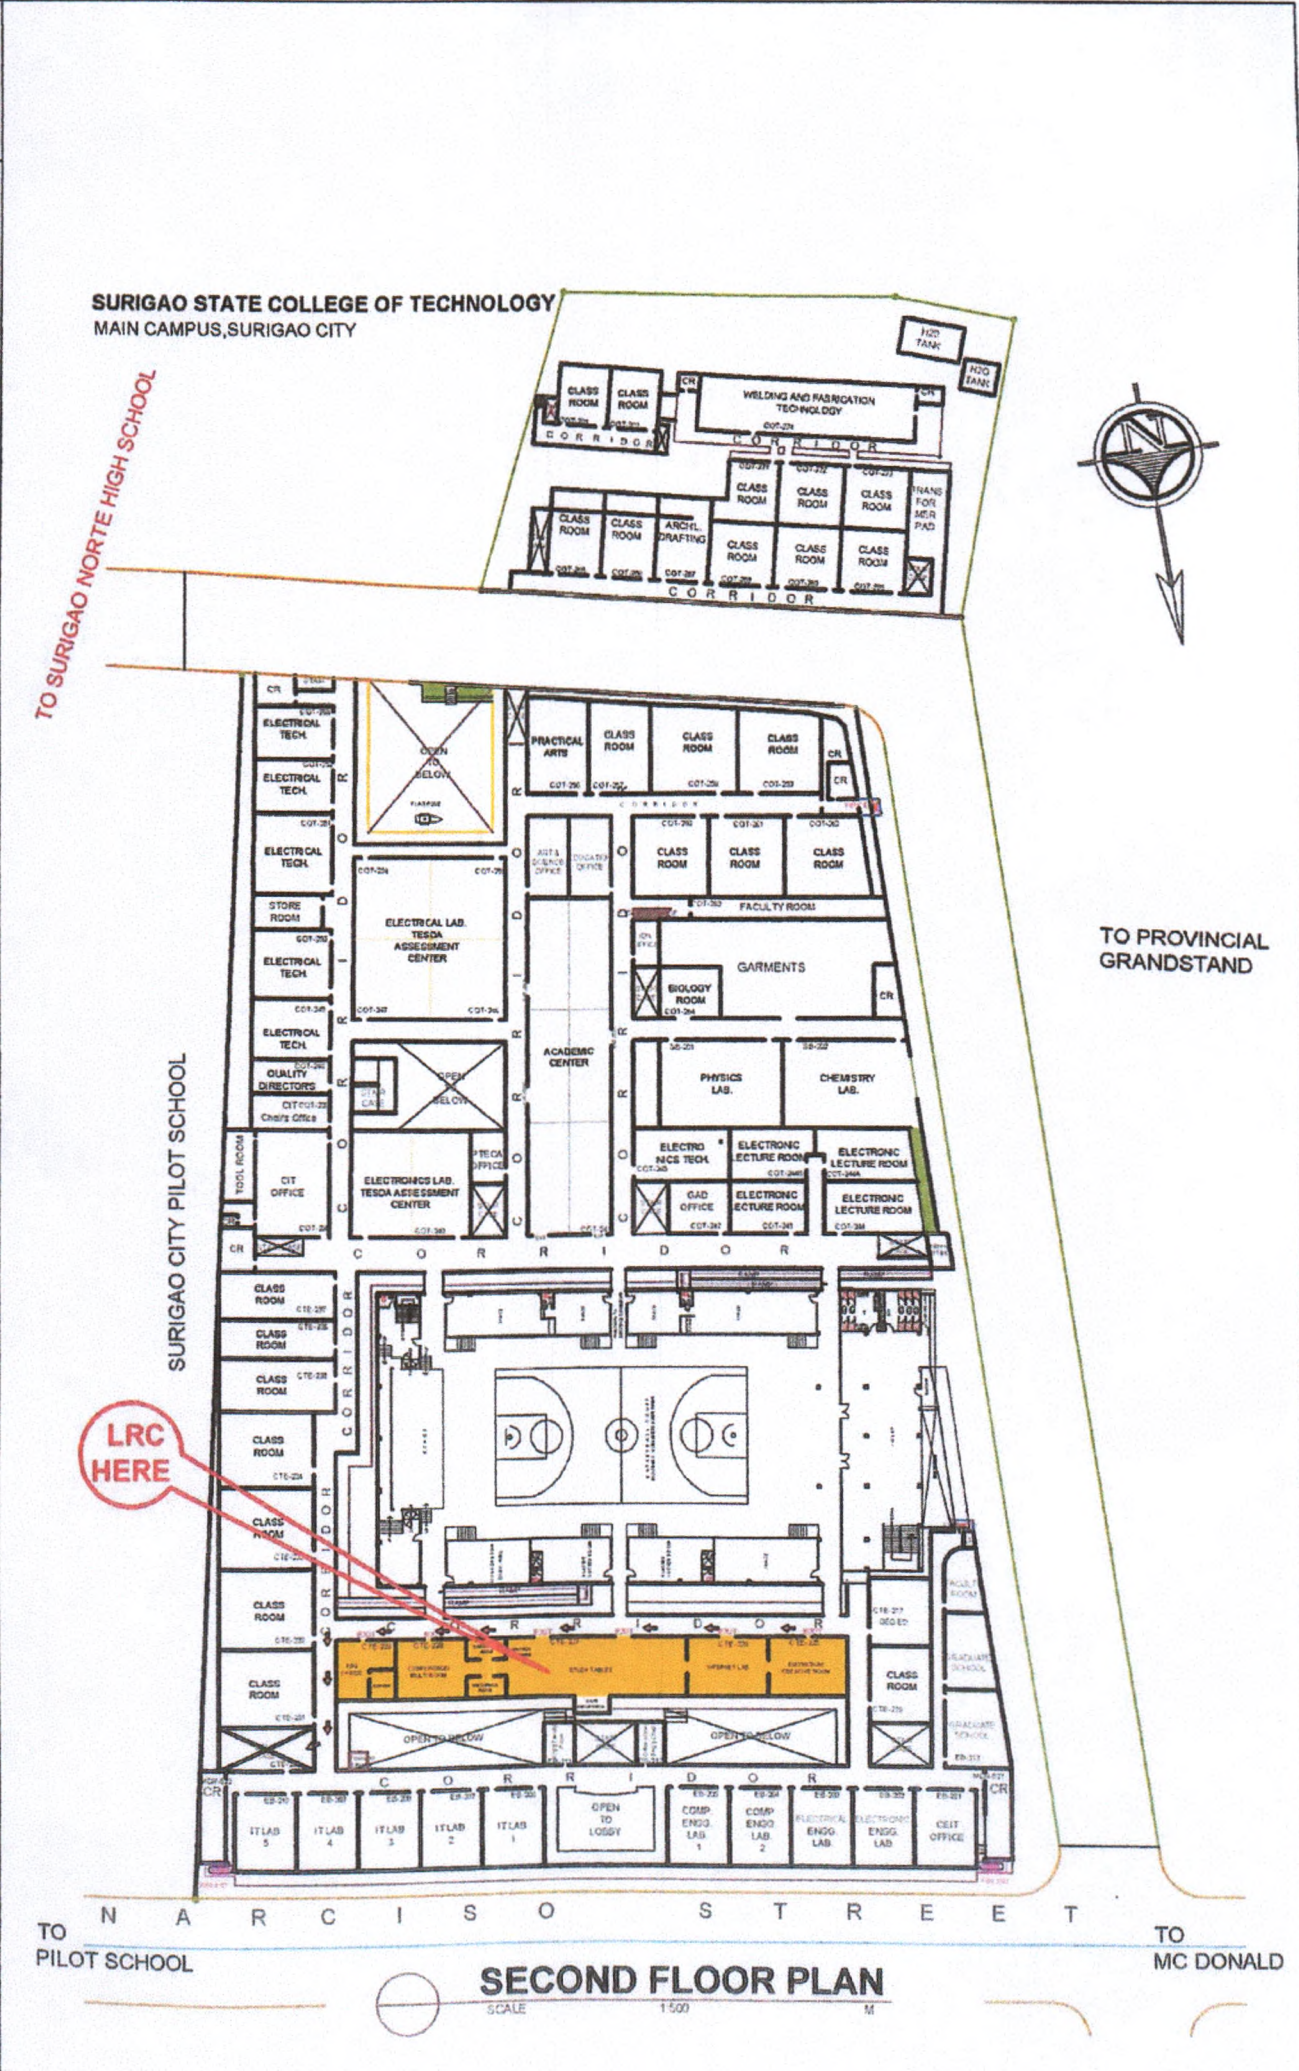


LEARNING RESOURCE CENTER

**SURIGAO STATE COLLEGE OF TECHNOLOGY
MAIN CAMPUS, SURIGAO CITY**

EVACUATION AREA

TO SURIGAO NORTE HIGH SCHOOL

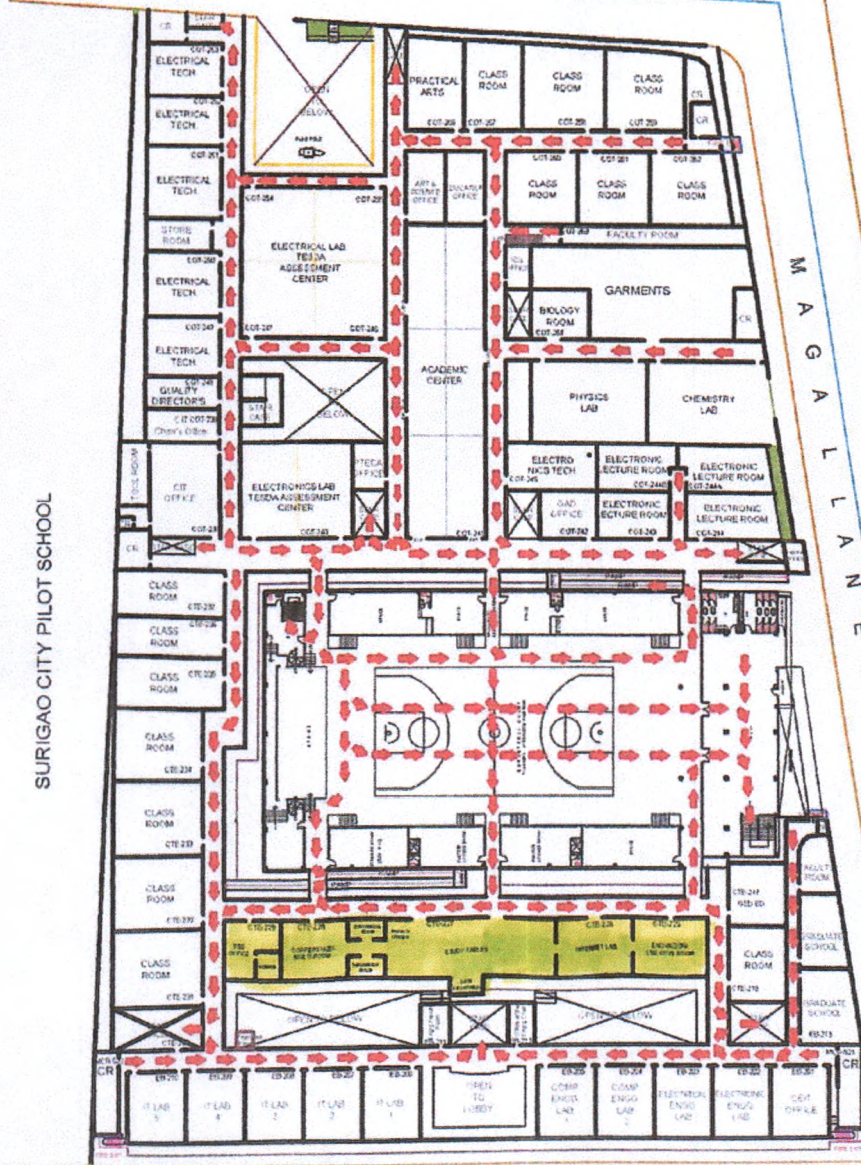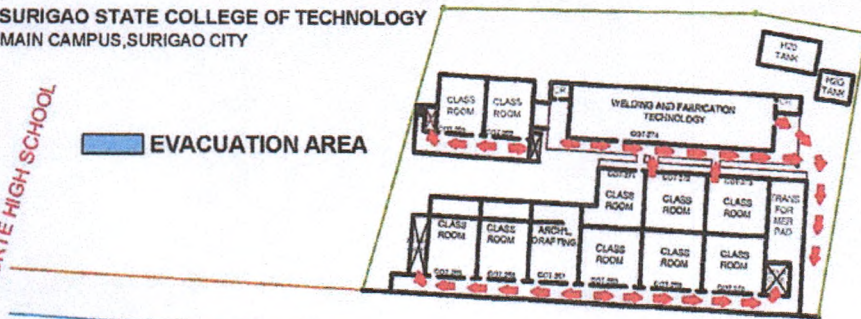


SURIGAO CITY PILOT SCHOOL

EMERGENCY NUMBER

BFP: 232-7790/827-0318
 CRH: 862-1800/826-3876
 PNP HOTLINE: 09209746322
 PDRRC: 09282105287
 CDRRC: 826-5449/09106217684
 RESCUE: 09284209511

PROVINCIAL SPORTS
COMPLEX

TO PROVINCIAL
GRANDSTAND

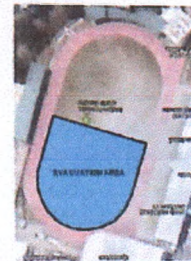

MAGALLANES EXTENSION


TO NARCISO STREET
PILOT SCHOOL

TO MC DONALD

SECOND FLOOR PLAN

SCALE 1:500 M

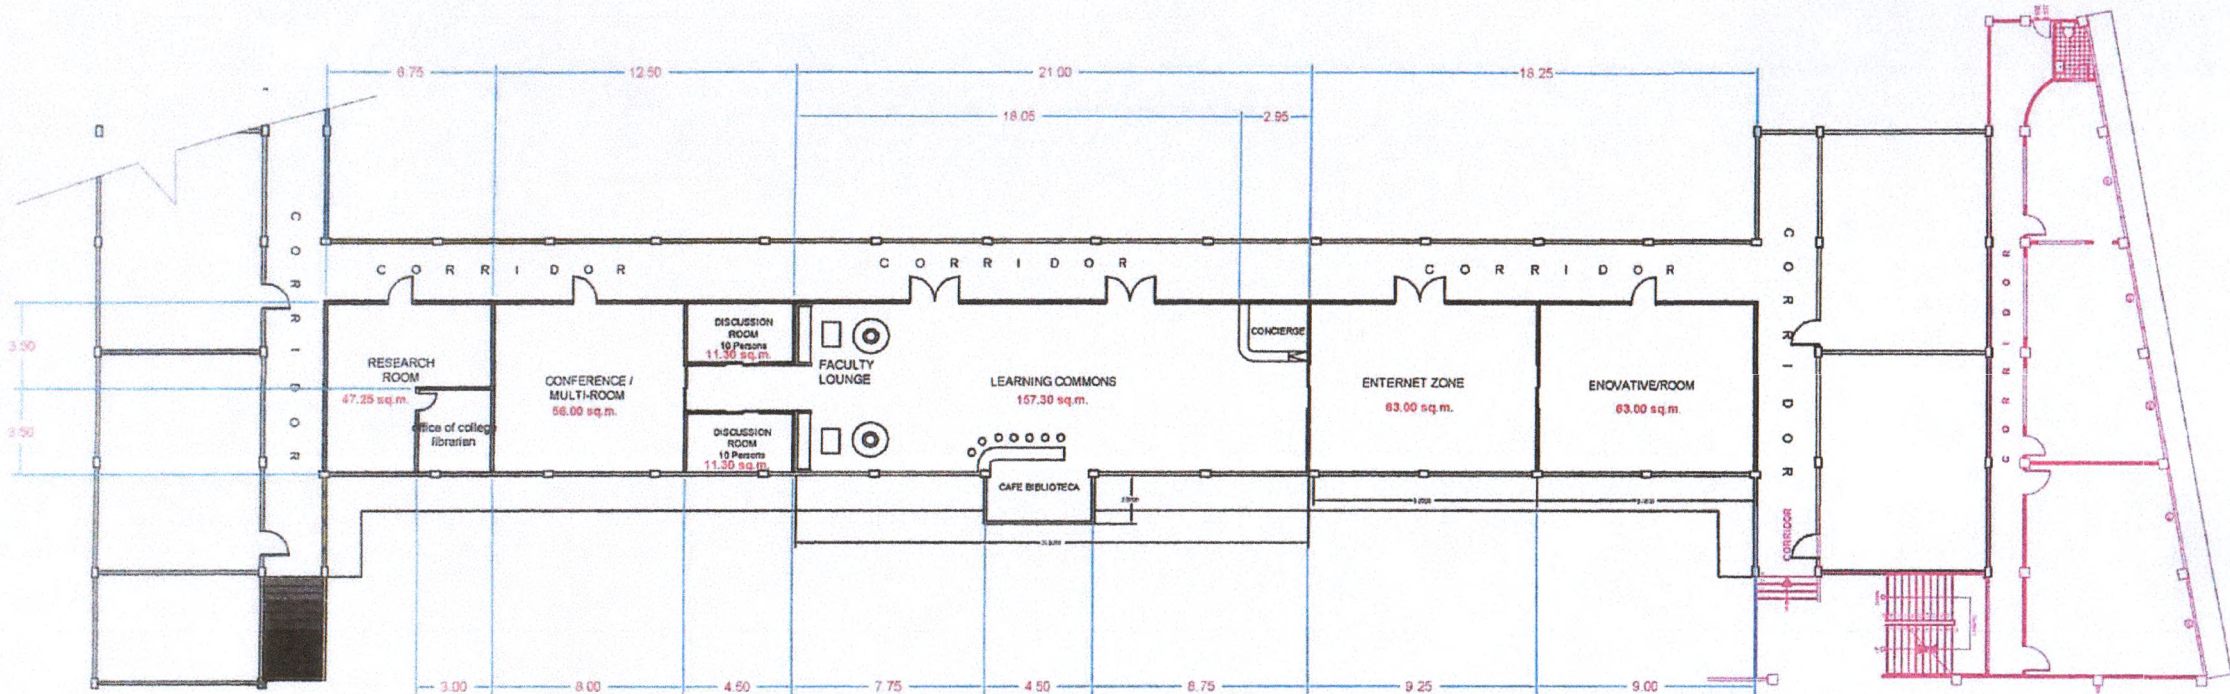


 
 
LOGO	BY DIRECT SUPERVISION	PROJECT TITLE	RECOMMENDING APPROVAL	APPROVED	SHEET CONTENTS	SHEET NO.
	 AR. MARLON C. SOLLOS	EMERGENCY EXIT PLAN/ EVACUATION EXIT PLAN	 ROWENA A. PRADO, Ph.D. VICE PRESIDENT for ADMINISTRATION	 GREGORIO Z. GAMBOA, JR., Ed.D. COLLEGE PRESIDENT		⊕
SSCT	HEAD BUILDINGS & ESTATES	LOCATION: SSCT-MAIN CAMPUS, NARCISO ST., SURIGAO CITY				




AREA 555.75 SQ.

SECOND FLOOR PLAN
SCALE 1:300 M.

**SEATING CAPACITY: 500 STUDENTS
(LEARNING RESOURCE CENTER)**

COLLEGE LOGO:	BY DIRECT SUPERVISION :	PROJECT TITLE :	RECOMMENDING APPROVAL:	APPROVED:	CONTENT:	SHEET: NO.:
	 AR. MARLON C. SOLLOSO	LEARNING RESOURCE CENTER	 ROWENA A. PLANDO, Ph.D.	 GREGORIO Z. GAMBOA, Jr., Ed.D		
SSCT	HEAD BUILDINGS & ESTATES	LOCATION: SSCT-MAIN CAMPUS, SURIGAO CITY, SDN	VICE-PRESIDENT for ADMINISTRATION	COLLEGE PRESIDENT		

COPYRIGHT © CAD JONAS E. DELACRUZ ALL RIGHTS RESERVED - 2019

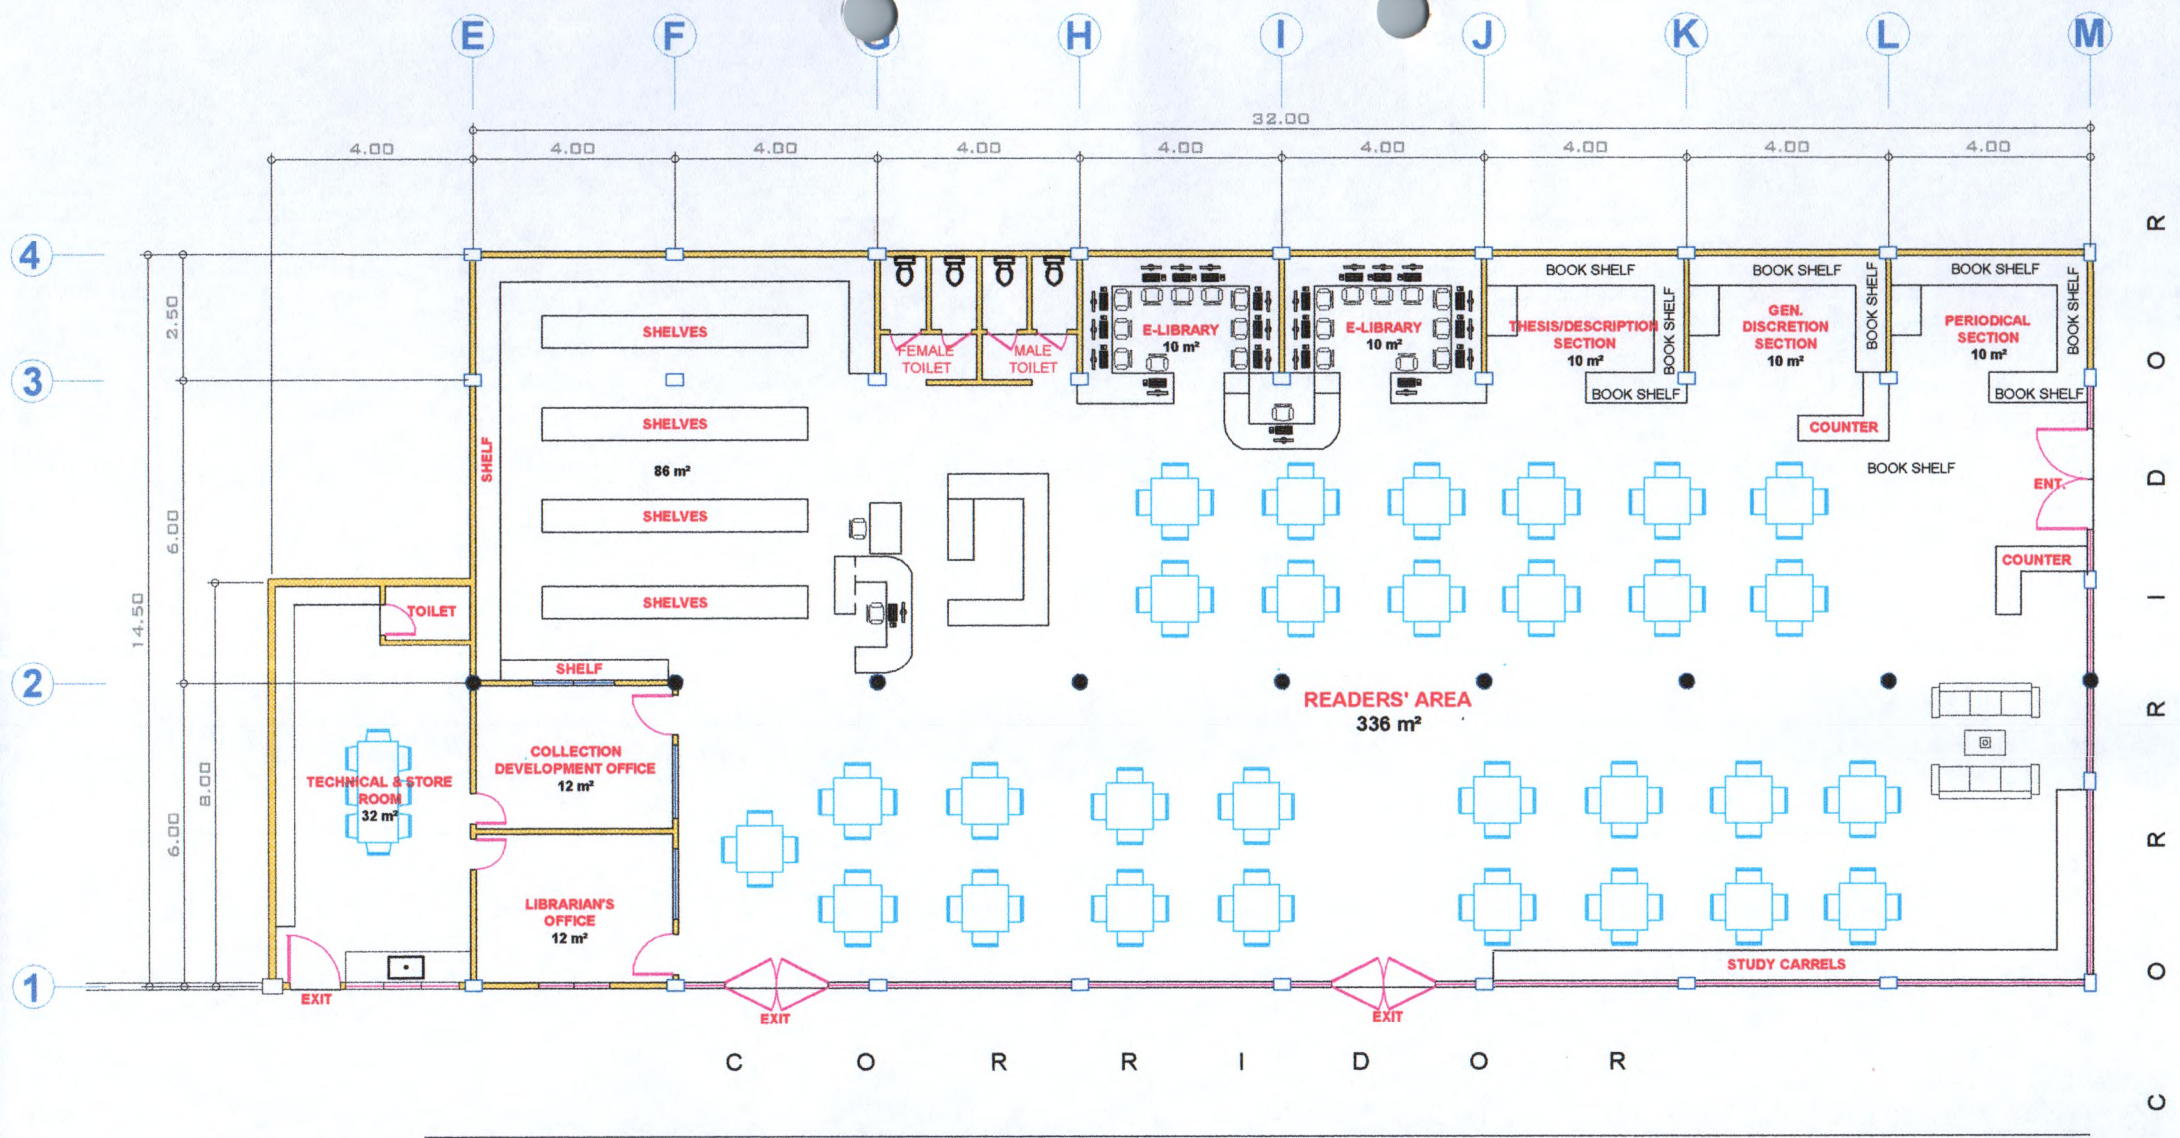

AREA 496 SQ.

FLOOR PLAN
SCALE: 1:150 METERS

**SEATING CAPACITY: 300 STUDENTS
(MAIN LIBRARY and LRC)**

COLLEGE LOGO:	BY DIRECT SUPERVISION:	PROJECT TITLE:	RECOMMENDING APPROVAL:	APPROVED:	CONTENT:	SHEET: NO.:
		COLLEGE LIBRARY LAYOUT PLAN				
SSCT	HEAD BUILDINGS & ESTATES	LOCATION: SSCT-MAIN CAMPUS, SURIGAO CITY, SDN	ROWENA A. PLANDO, Ph.D. VICE-PRESIDENT for ADMINISTRATION	GREGORIO Z. GAMBOA, JR., Ed.D. COLLEGE PRESIDENT		